


Piping Plan Reference : N/A  
 Pipe Specification : ???  
 Fabrication and Welding Code : BS 2971 CL 2  
 M.D.T. Requirement : ???  
 Painting/Finish Requirement : Red Oxide??  
 End Protection : PLASTIC CAPS  
 Material Traceability Requirement : N/A

No. Off	Item No.
1	COND-F10
1	COND-F11
1	COND-F12
1	COND-F13
1	COND-R6
1	COND-R7

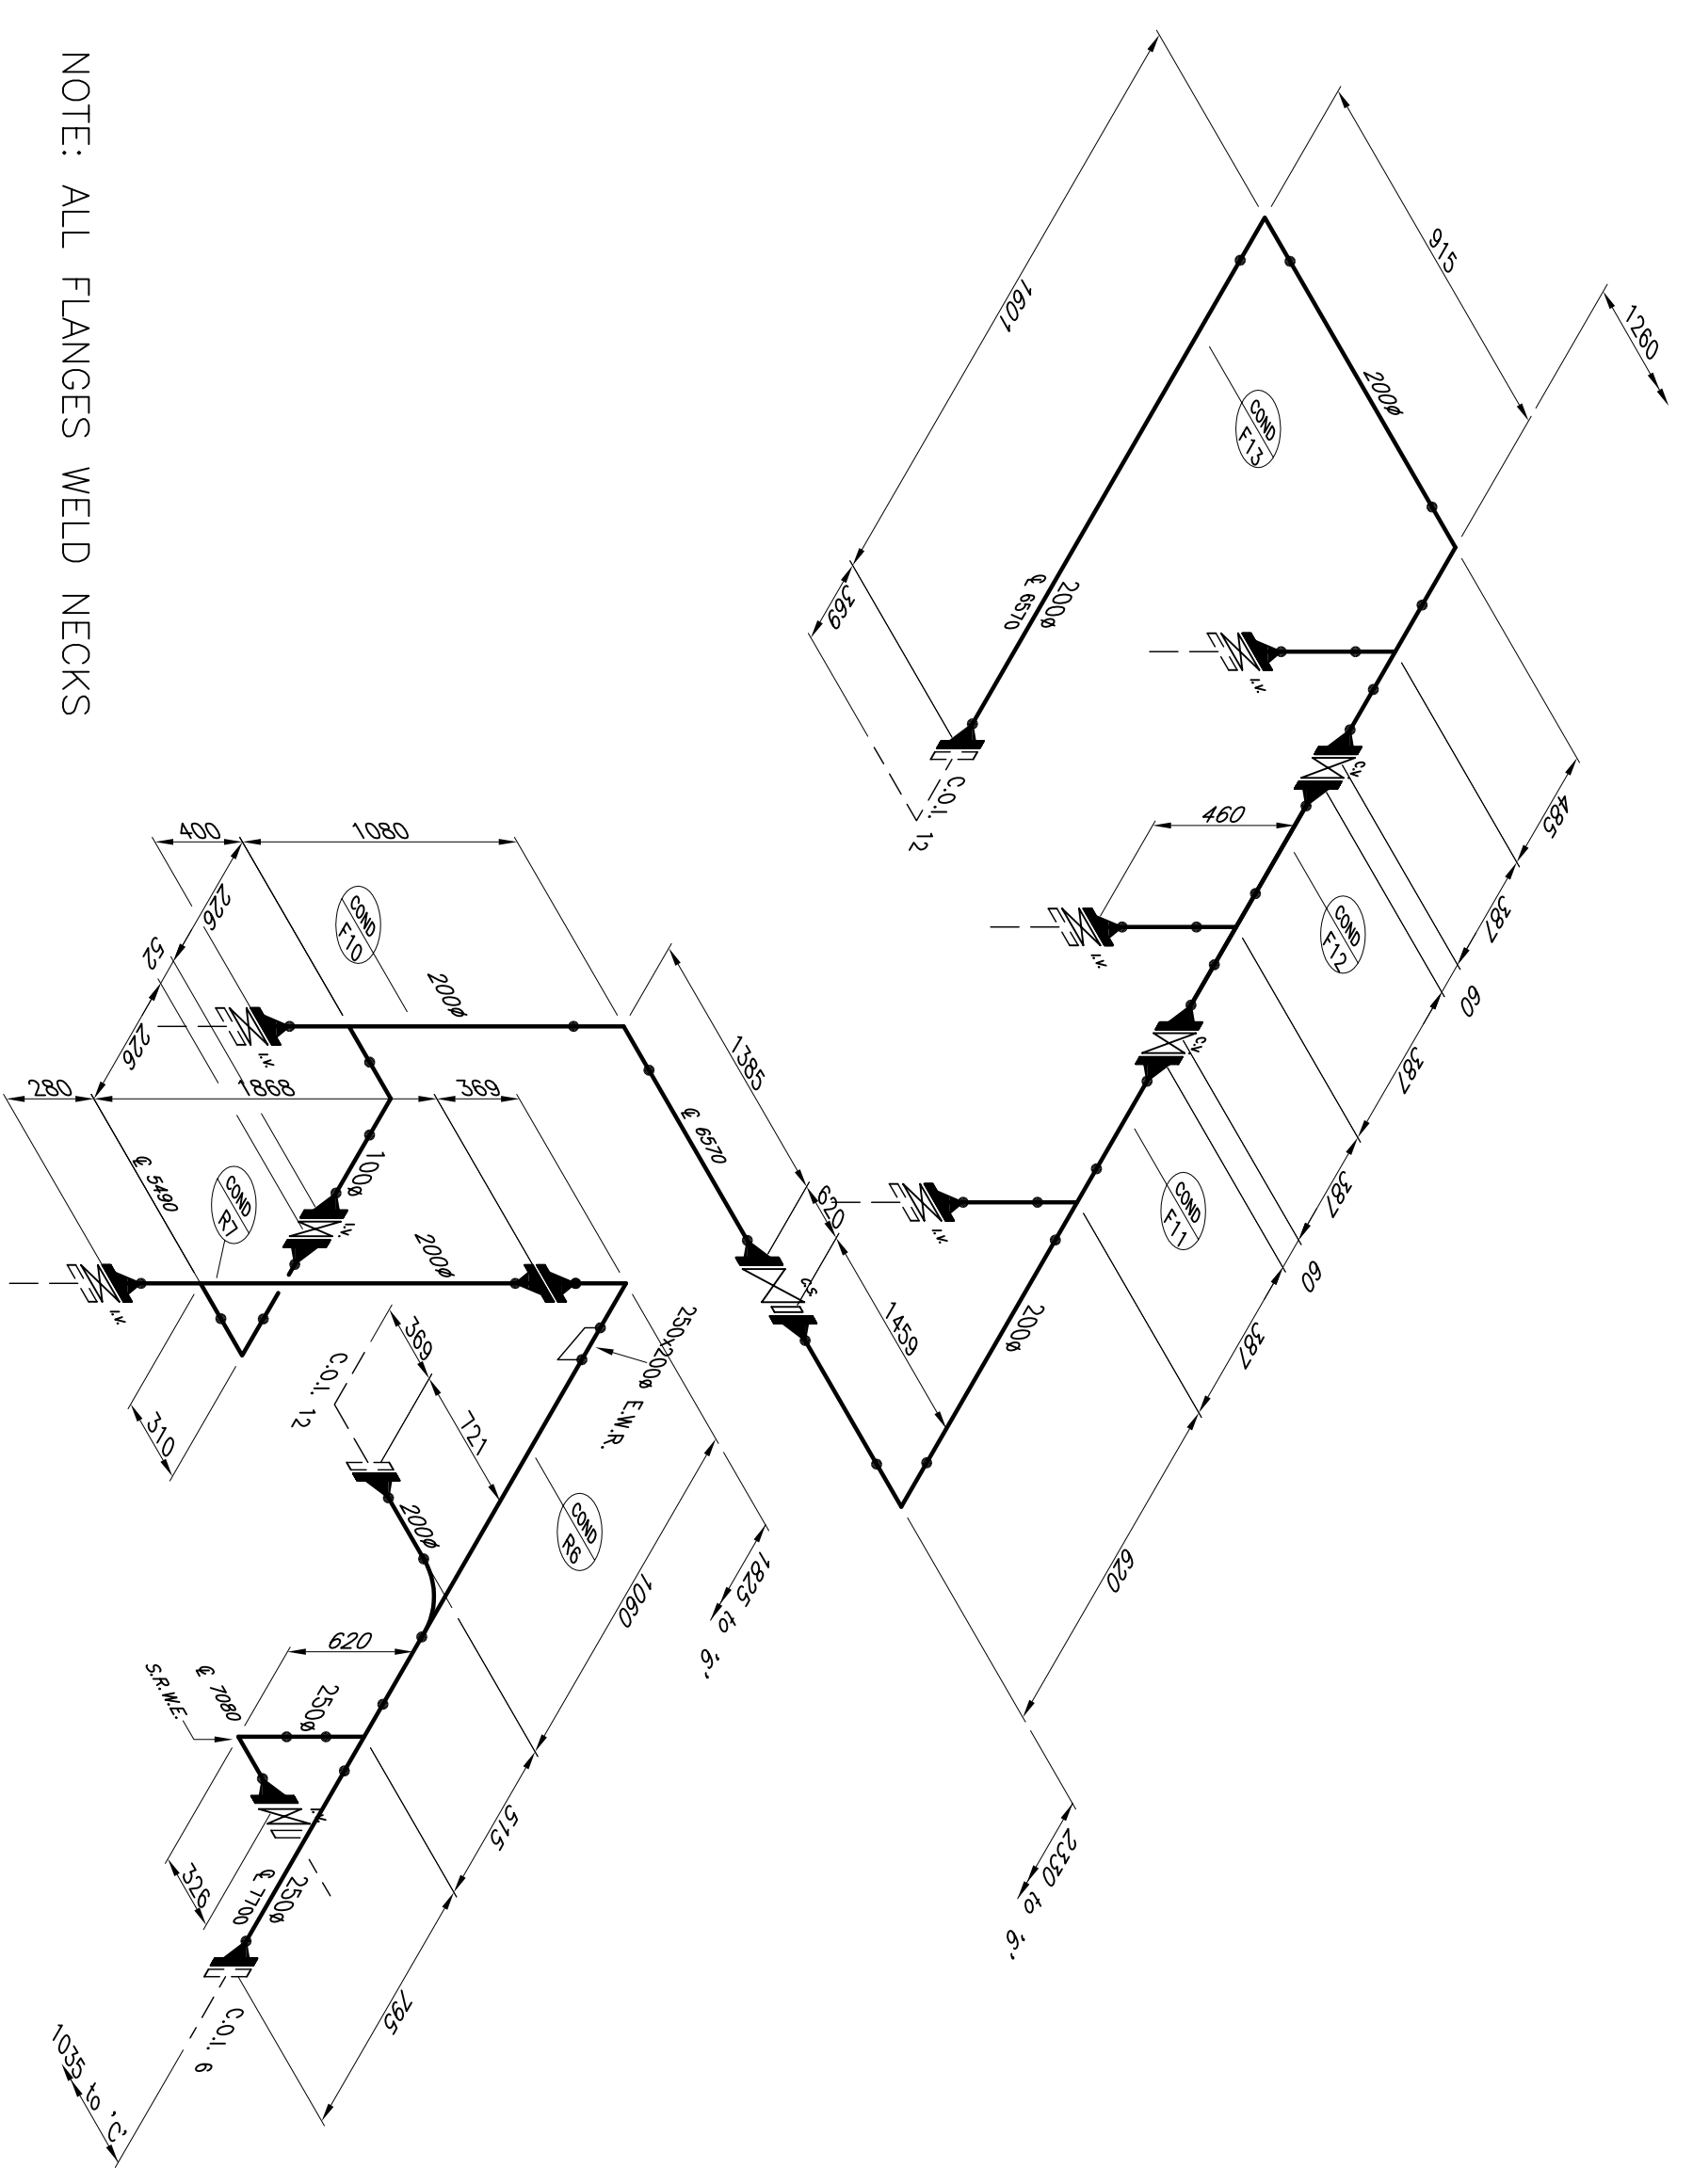

NOTE: ALL FLANGES WELD NECKS

- Notes
1. All flanges are PN16 face unless otherwise noted.
  2. Where a flange is left loose, or a pipe marked with M.L.W., a pipe must be left at least 150mm longer than given dimensions to field fit.
  3. Unless stated otherwise, all dimensions and elevations to be centre line of pipe, all bends 90 deg., and all butt-weld elbows are L.R.E.

Rev.	Date	Description of Revision	By	CHK	By	CHK
A	09-10	ISSUE FOR FABRICATION	CJH	/	/	/

Client		Drawn By	CJH
Contract		Checked By	N/A
Location	Basement Chiller Room	Description	250x200 Cond F/R
Job No.		Sheet No.	11
Rev.		Rev.	A